


P:\PDX PROJECTS\2017\17-023 Kitsap County Parks - Waterless Restroom\CAD\2-Sheets\Civil\C-03\_CIVIL SITE PLAN.dwg 9/7/2017 4:50 PM  
 COPYRIGHT 2015, AKANA. ALL RIGHTS RESERVED

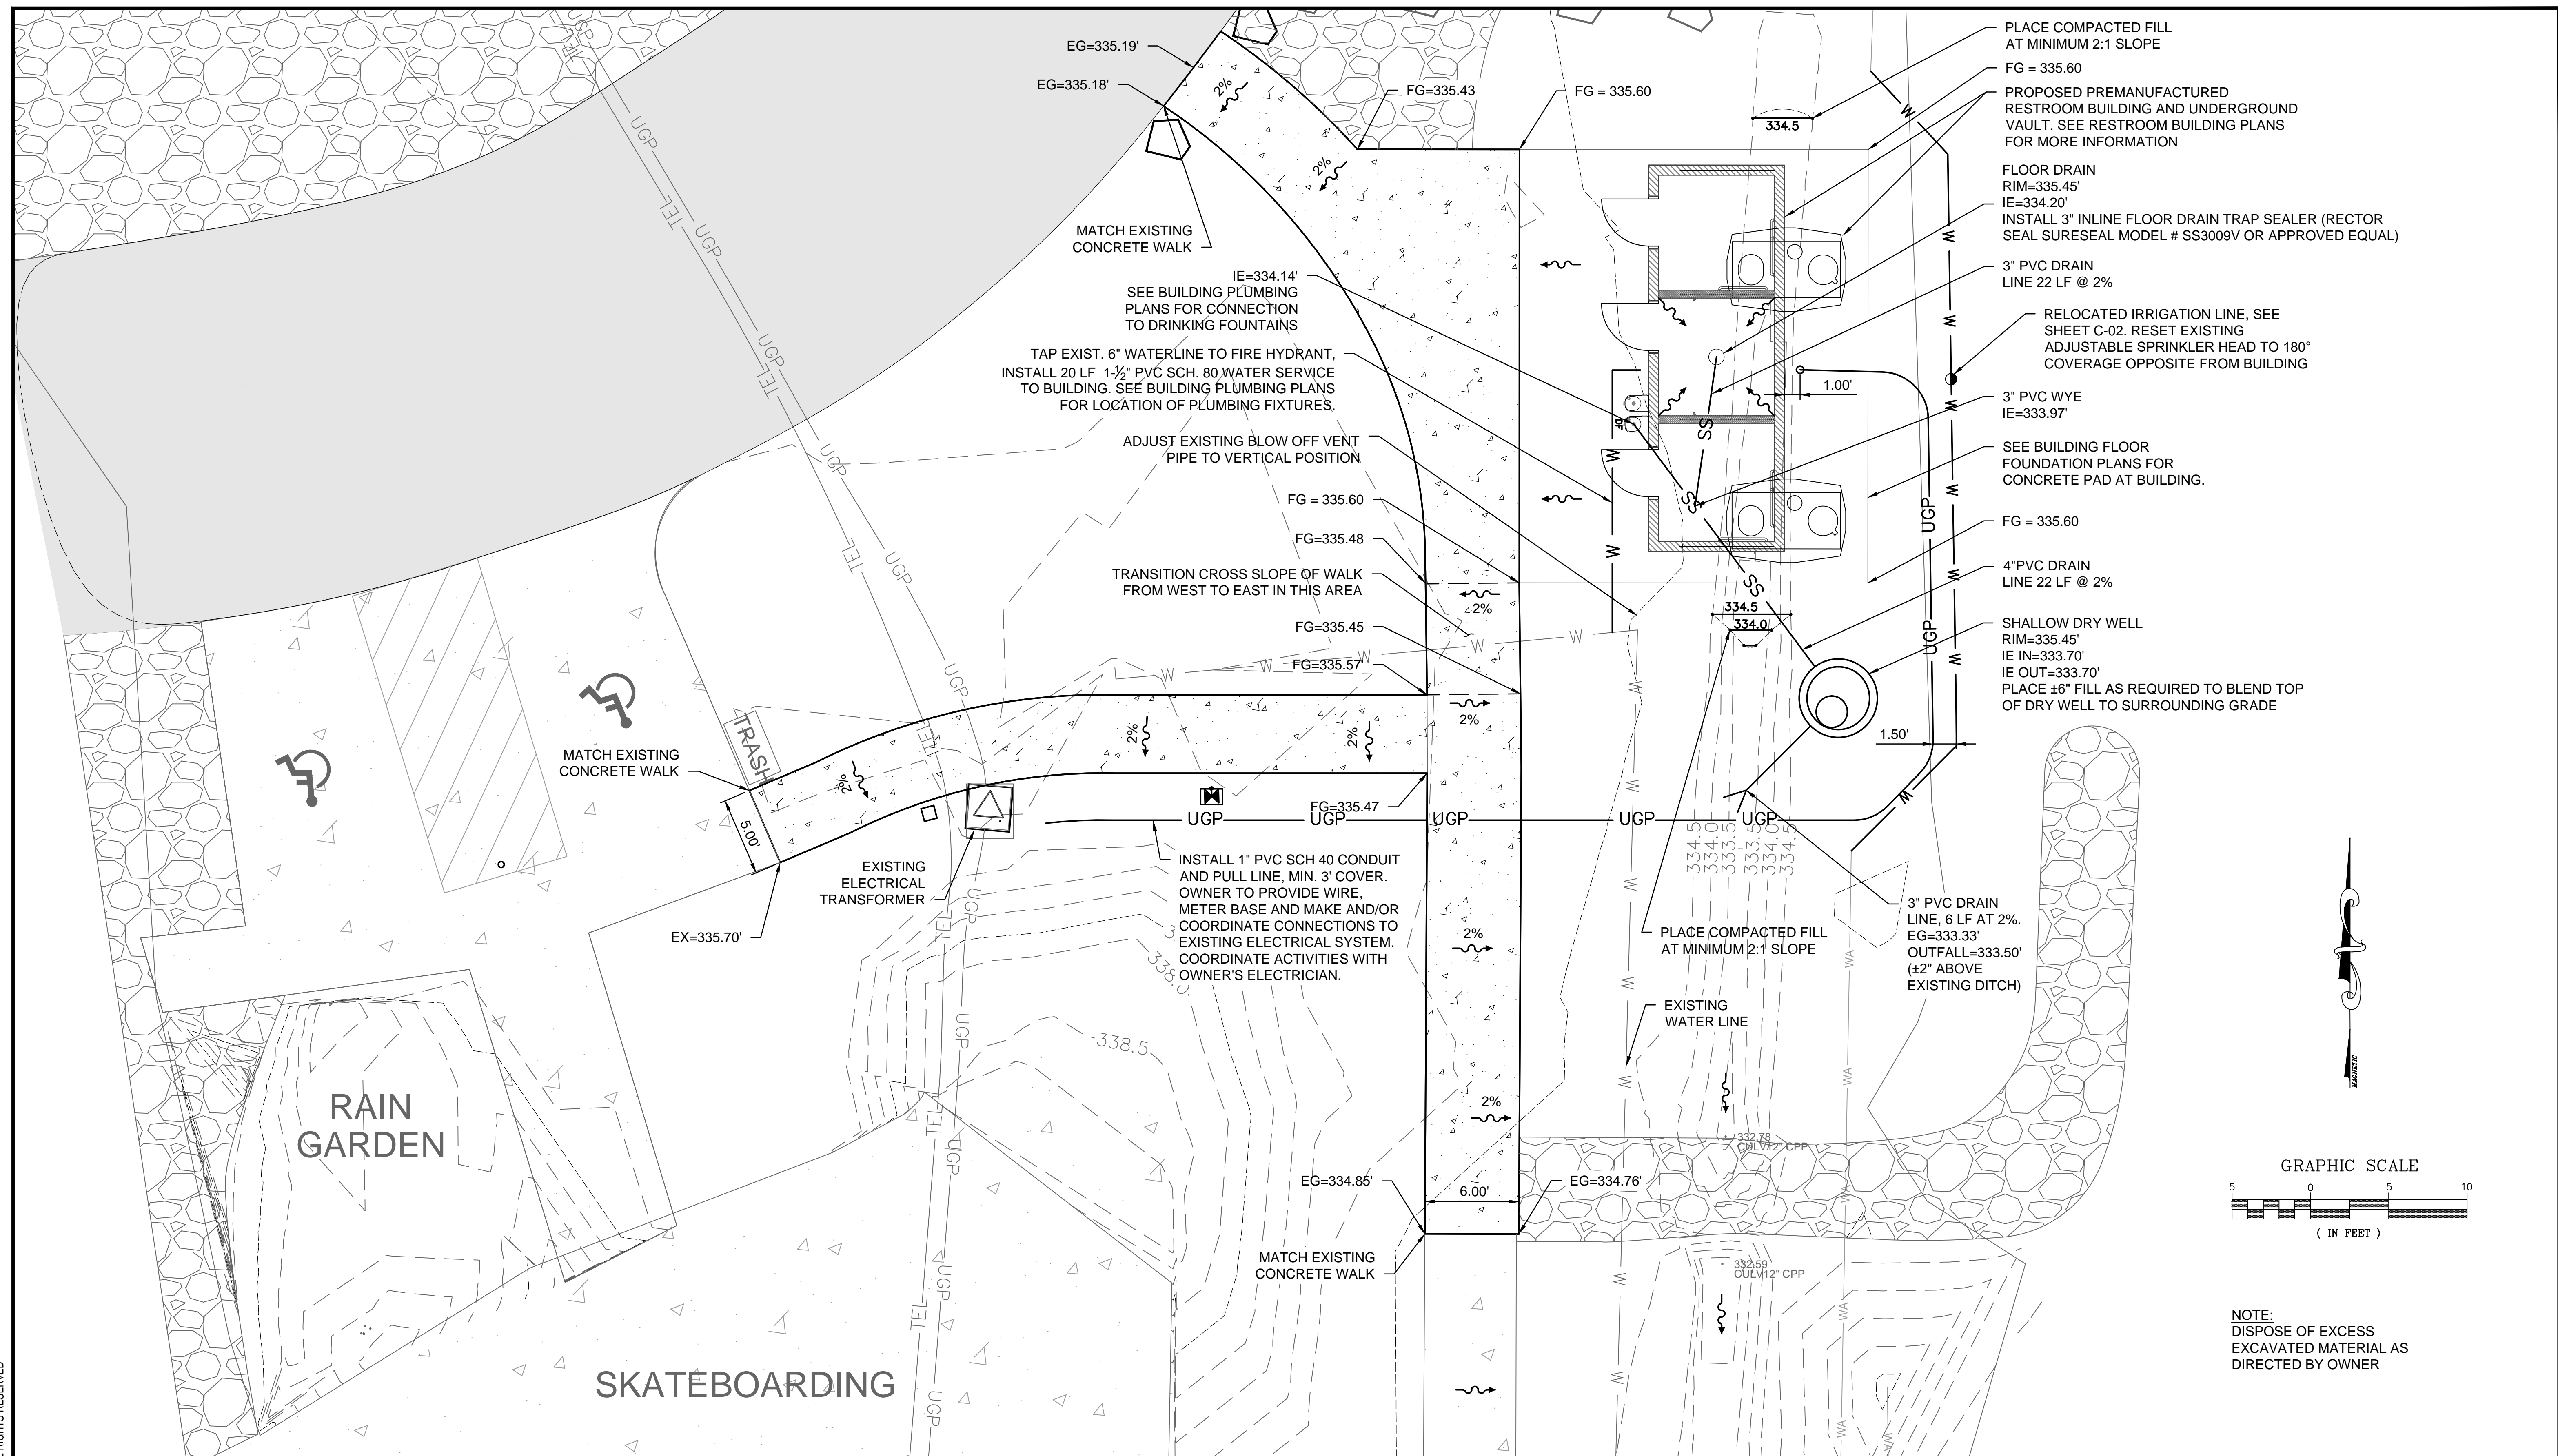

NO.	DATE	BY	REVISIONS

**AKANA**  
 Plan + Design + Engineer + Manage




6400 SE Lake Road, Ste 270  
 Portland, Oregon 97222  
 Voice (503) 652-9090

**KITSAP COUNTY PARKS DEPARTMENT**

1195 NW FAIRGROUNDS RD.  
 BREMERTON, WA 98311  
 360-337-5350

DESIGNED BY	RPK
DRAWN BY	TLH
CHECKED BY	CZ
DRAWING DATE	07/14/2017

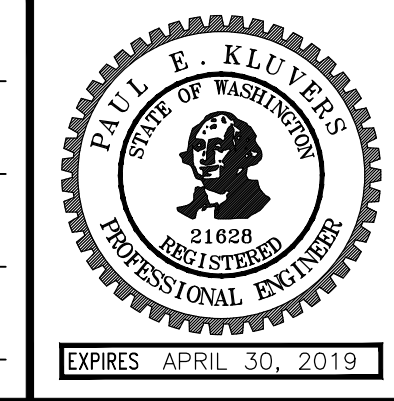

**SOUTH KITSAP REGIONAL PARK**  
**WATERLESS RESTROOM**  
**CIVIL SITE PLAN**

JOB NO. 17-023  
 SHEET NO. **C-03**  
 3 OF 4